


NOTES

- SMSB - ELECTRICAL SHALL REPLACE THE EXISTING 32A CIRCUIT BREAKER INSIDE THE SMSB WITH AN ADJUSTABLE 63A CIRCUIT BREAKER AND SET THE CIRCUIT BREAKER AS FOLLOW: 47A / 63A

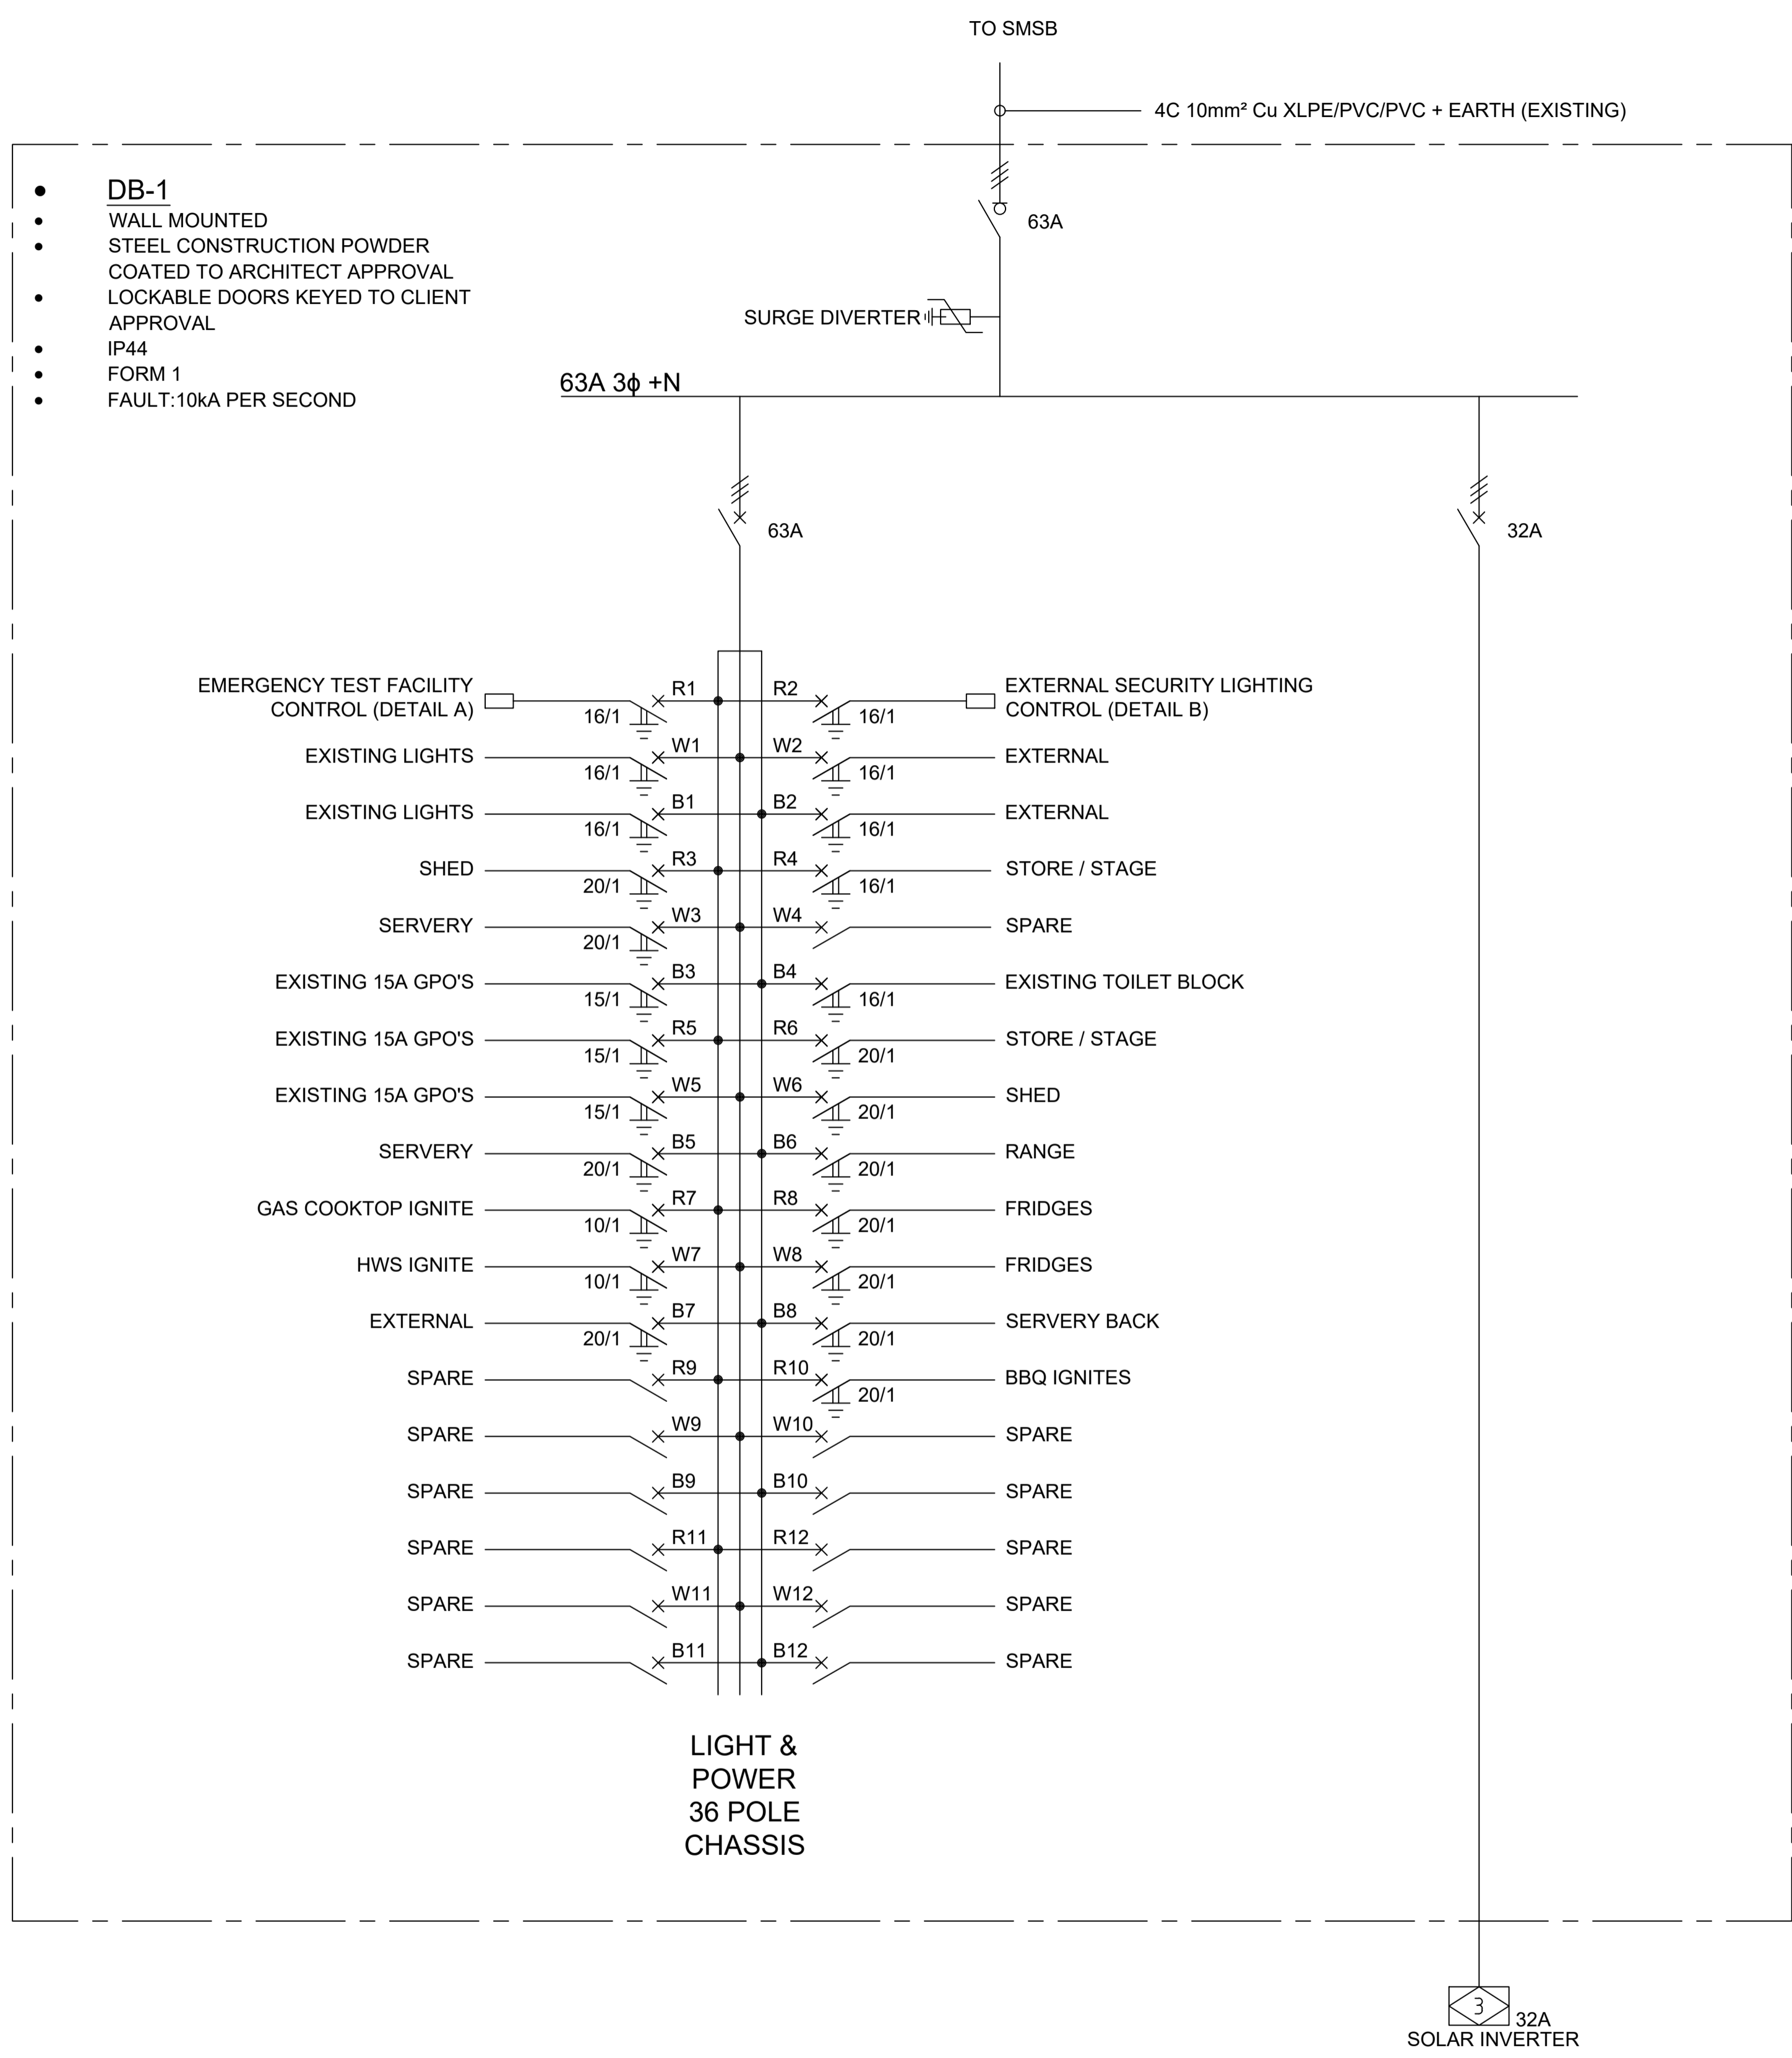


- DB-1
- WALL MOUNTED
- STEEL CONSTRUCTION POWDER COATED TO ARCHITECT APPROVAL
- LOCKABLE DOORS KEYED TO CLIENT APPROVAL
- IP44
- FORM 1
- FAULT: 10kA PER SECOND

- ELECTRICAL CONTRACTOR SHALL COMPLY WITH ALL AUSTRALIAN STANDARDS AND NCC (BCA) STANDARDS INDICATED BUT NOT LIMITED TO THE SCHEDULE BELOW:
- AS/NZS3000 WIRING RULES
 - AS3008.1 ELECTRICAL INSTALLATION - SELECTION OF CABLES
 - AS2299.1 EMERGENCY LIGHTING IN BUILDINGS
 - AS3080 TELECOMMUNICATIONS INSTALLATIONS
 - AS 3084 TELECOMMUNICATIONS INSTALLATIONS - TELECOMMUNICATIONS PATHWAYS AND SPACES FOR COMMERCIAL BUILDINGS
 - AS/NZS 3087.1 TELECOMMUNICATIONS INSTALLATIONS - GENERIC CABLING SYSTEMS - SPECIFICATION FOR THE TESTING OF BALANCED COMMUNICATION CABLING
 - AS/NZS 3087.2 TELECOMMUNICATIONS INSTALLATIONS - GENERIC CABLING SYSTEMS - SPECIFICATION FOR THE TESTING OF PATCH CORDS IN ACCORDANCE WITH AS/NZS 3086
 - HB 243 COMMUNICATIONS CABLING MANUAL, MODULE 1: AUSTRALIAN REGULATORY ARRANGEMENTS
 - AS/NZS 3086: TELECOMMUNICATIONS INSTALLATIONS - INTEGRATED TELECOMMUNICATIONS CABLING SYSTEMS FOR SMALL OFFICE/HOME OFFICE PREMISES
 - AS/AC/IF 509 INSTALLATION REQUIREMENTS FOR CUSTOMER CABLING (WIRING RULES)
 - AS/AC/IF 508 REQUIREMENTS FOR AUTHORISED CABLING PRODUCTS
 - AS/AC/IF REGULATIONS AND STANDARDS
 - HB 29 COMMUNICATIONS CABLING MANUAL (CCM)
 - TS 010 GENERAL PREMISES AND DOMESTIC CABLE INSTALLERS' LICENSE AND INSPECTION REQUIREMENTS
 - TS 011 ABBREVIATIONS, DEFINITIONS AND TERMS USED IN TECHNICAL STANDARDS
 - AS/ISO1 INTRUDER ALARM SYSTEMS
 - AS1670 FIRE DETECTION, WARNING, CONTROL AND INTERCOM SYSTEMS SYSTEM DESIGN, INSTALLATION AND COMMISSIONING - FIRE
 - AS1428 - 2021 ACCESS AND MOBILITY STANDARD
 - WESTERN POWER REGULATIONS AND STANDARDS
 - OFFICE OF ENERGY WAER, AND OTHER APPLICABLE DOCUMENTS
 - ASA REGULATIONS
 - LOCAL BUILDING AUTHORITIES
 - FESA
 - BUILDING CODE OF AUSTRALIA (BCA AND NCC)
 - WORKSAFE AUSTRALIA

NOTE

ELECTRICAL CONTRACTOR AND SWITCHBOARD MANUFACTURER SHALL REFER TO ALL WESTERN POWER DESIGN DRAWINGS (S) PRIOR TO ISSUING SHOP DRAWINGS, MANUFACTURING AND INSTALLATION OF THE SMSB AND CONFIRM ALL SPD QUANTITY, SPD SETTINGS, SMSB / SPD FAULT IKA RATING, METER TYPE, CT'S TYPE, ECT. ARE CORRECT AND COMPLIANT AS PER WESTERN POWER DESIGN DRAWING FOR THIS PROJECT / WESTERN POWER SINGLE LINE ISSUED DRAWING / WESTERN POWER STANDARDS.

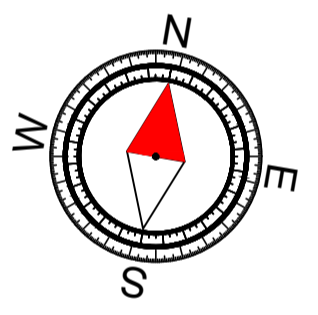

TENDER ISSUE
REFER TO REVISION COLUMN

REV	DETAILS	DATE	BY
0	TENDER AND CDC ISSUE	21/02/25	EHK

SEM Engineering Consultants
Ph: +61 8 99 99 21 91
E: deon@semconsultants.com
W: www.semconsultants.com

MCG Architects Pty Ltd
The Shire of Waroona, 93 S Western Highway, Waroona, SA 5215
T: 08 9492 1000 E: info@mcgarchitects.com.au



CLIENT
SHIRE OF WAROONA

PROJECT TITLE
WAROONA BIG SHED
93 S WESTERN HIGHWAY,
WAROONA, 6215

DRAWING TITLE
ELECTRICAL SERVICES
SINGLE LINE DIAGRAM

DESIGN D.K. DATE 12 July 2024

DRAWN E.H.K. SCALE N.T.S. (A1)

COPYRIGHT PROJECT NUMBER
P2024-030
DRAWING NUMBER REV
E 400 0